


REAR ELEVATION
SCALE: 1/4" = 1'-0"



LEFT ELEVATION
SCALE: 1/4" = 1'-0"

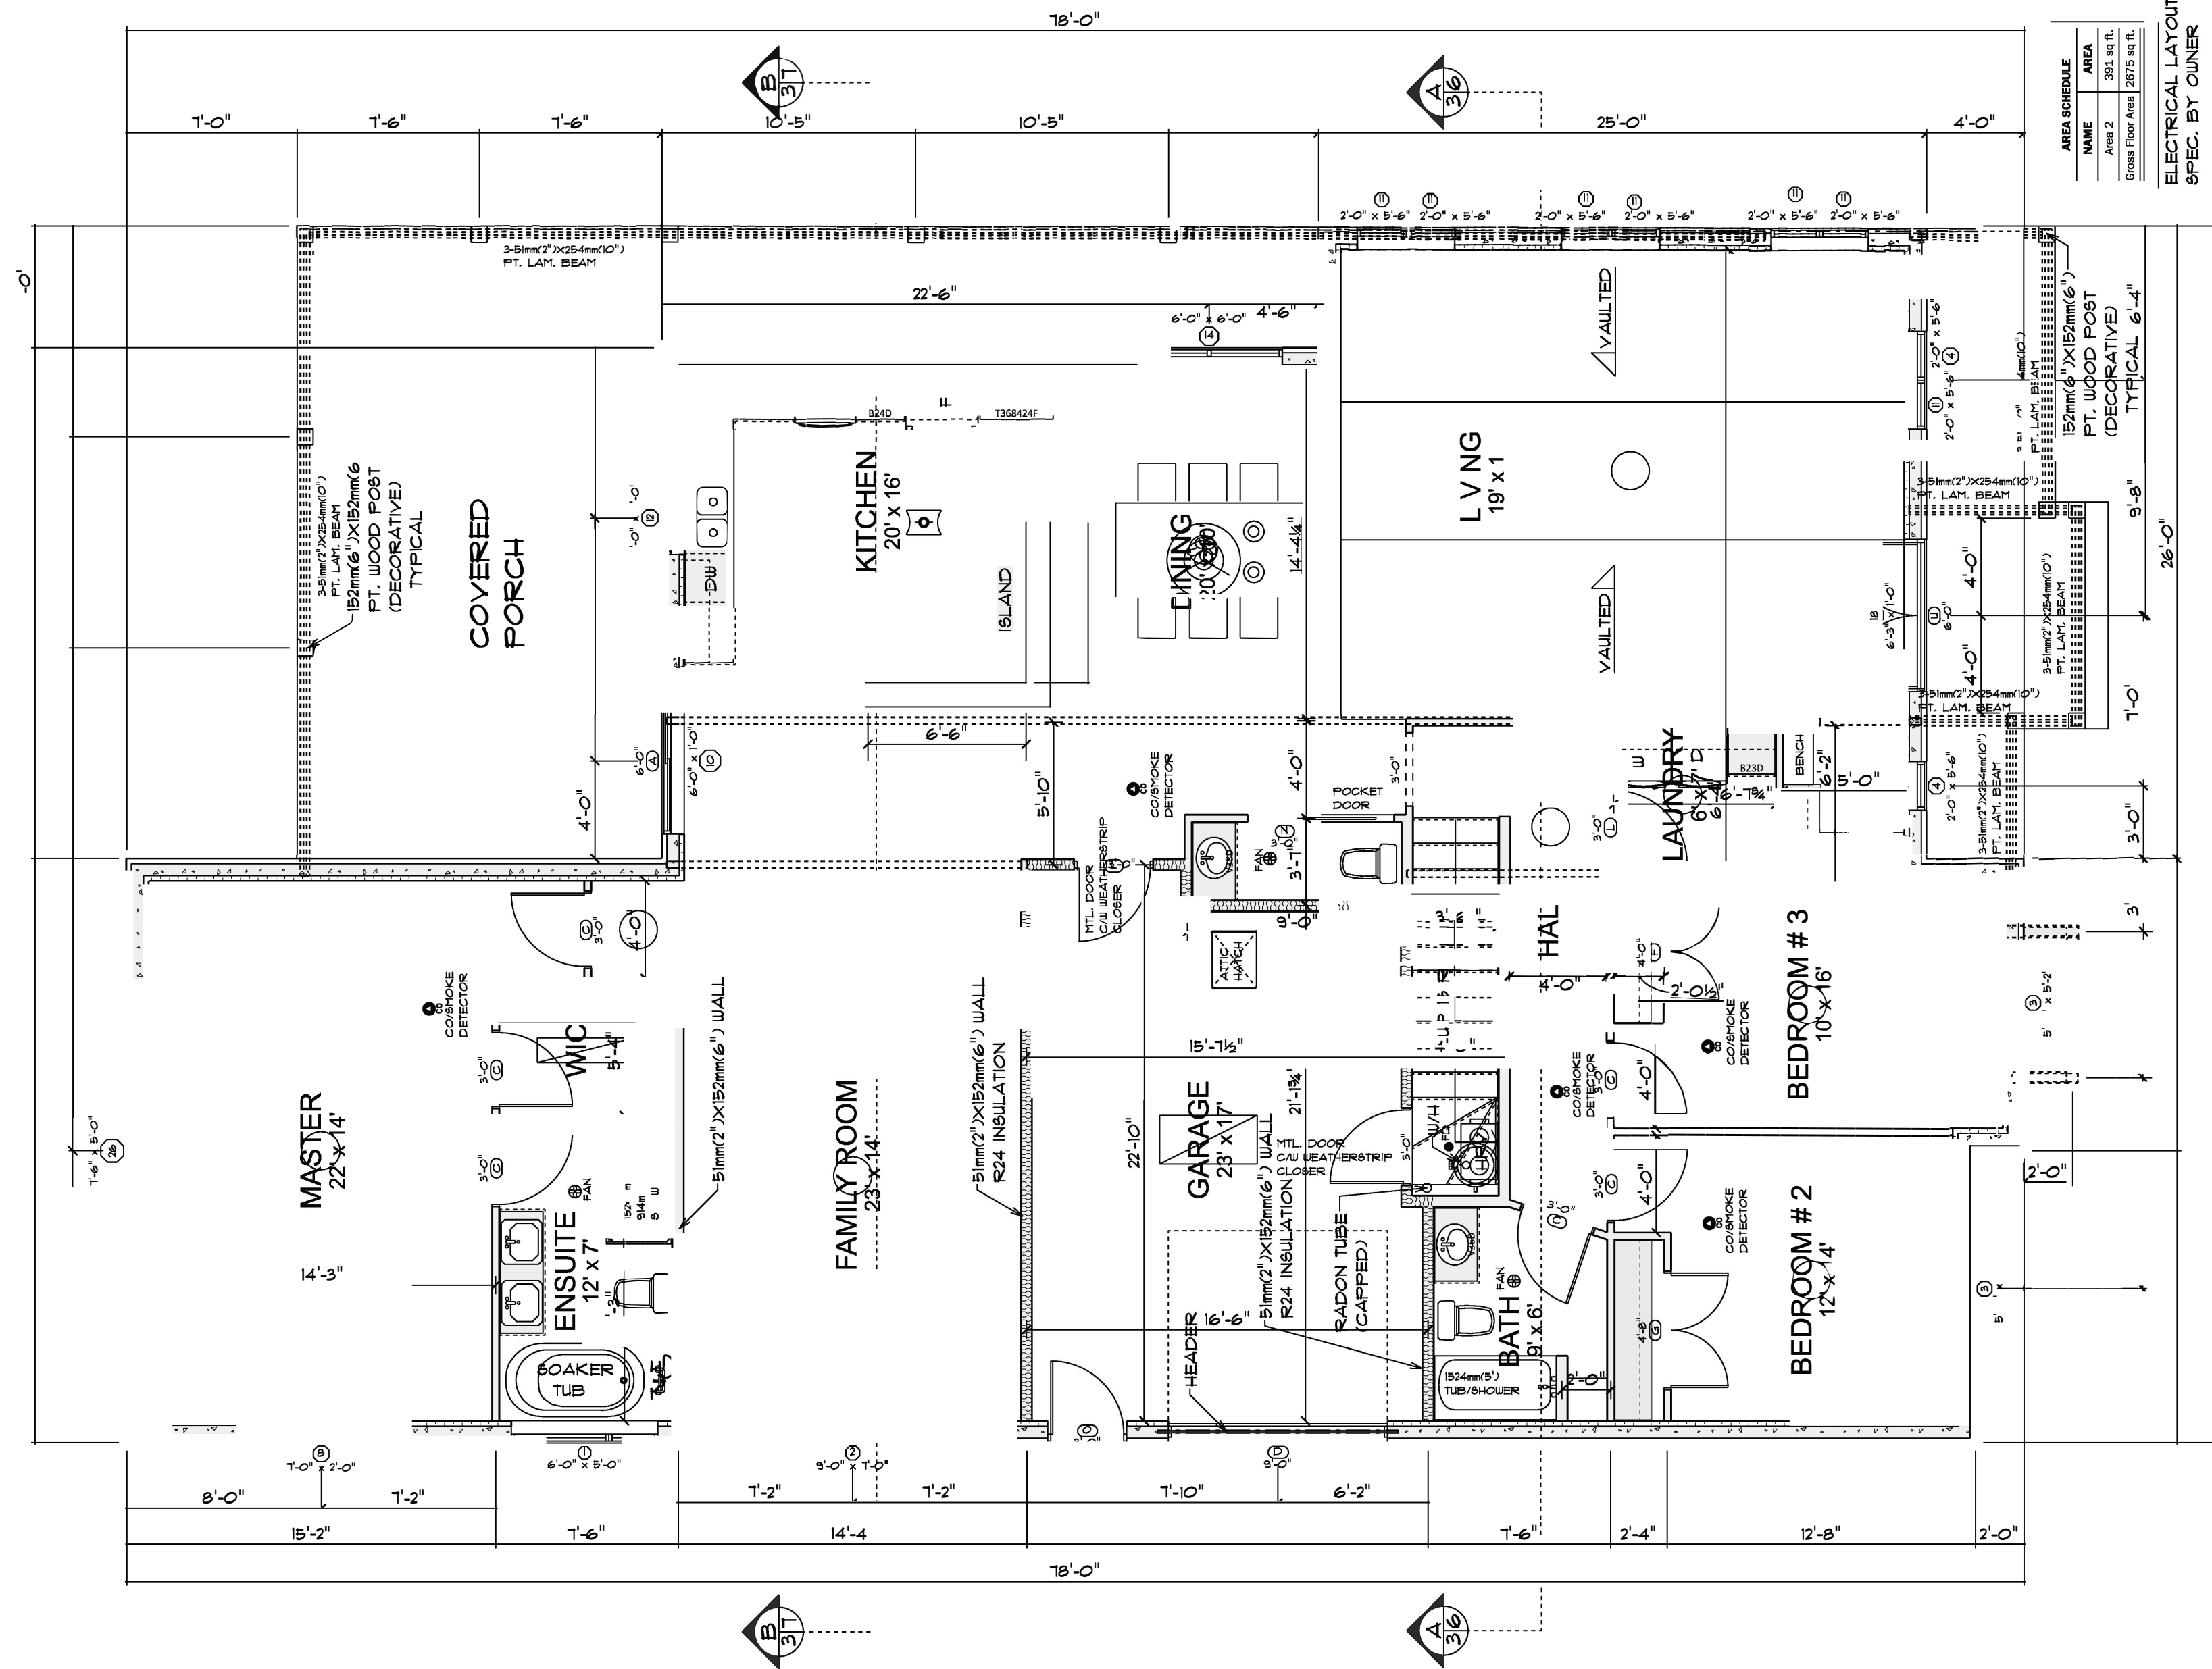


AREA SCHEDULE	
NAME	AREA
Area 2	391 sq. ft.
Gross Floor Area	2875 sq. ft.

ELECTRICAL LAYOUT
SPEC. BY OWNER

HEATING SYSTEM
SPEC. BY OWNER

MAIN FLOOR PLAN
SCALE: 3/16" = 1'-0"

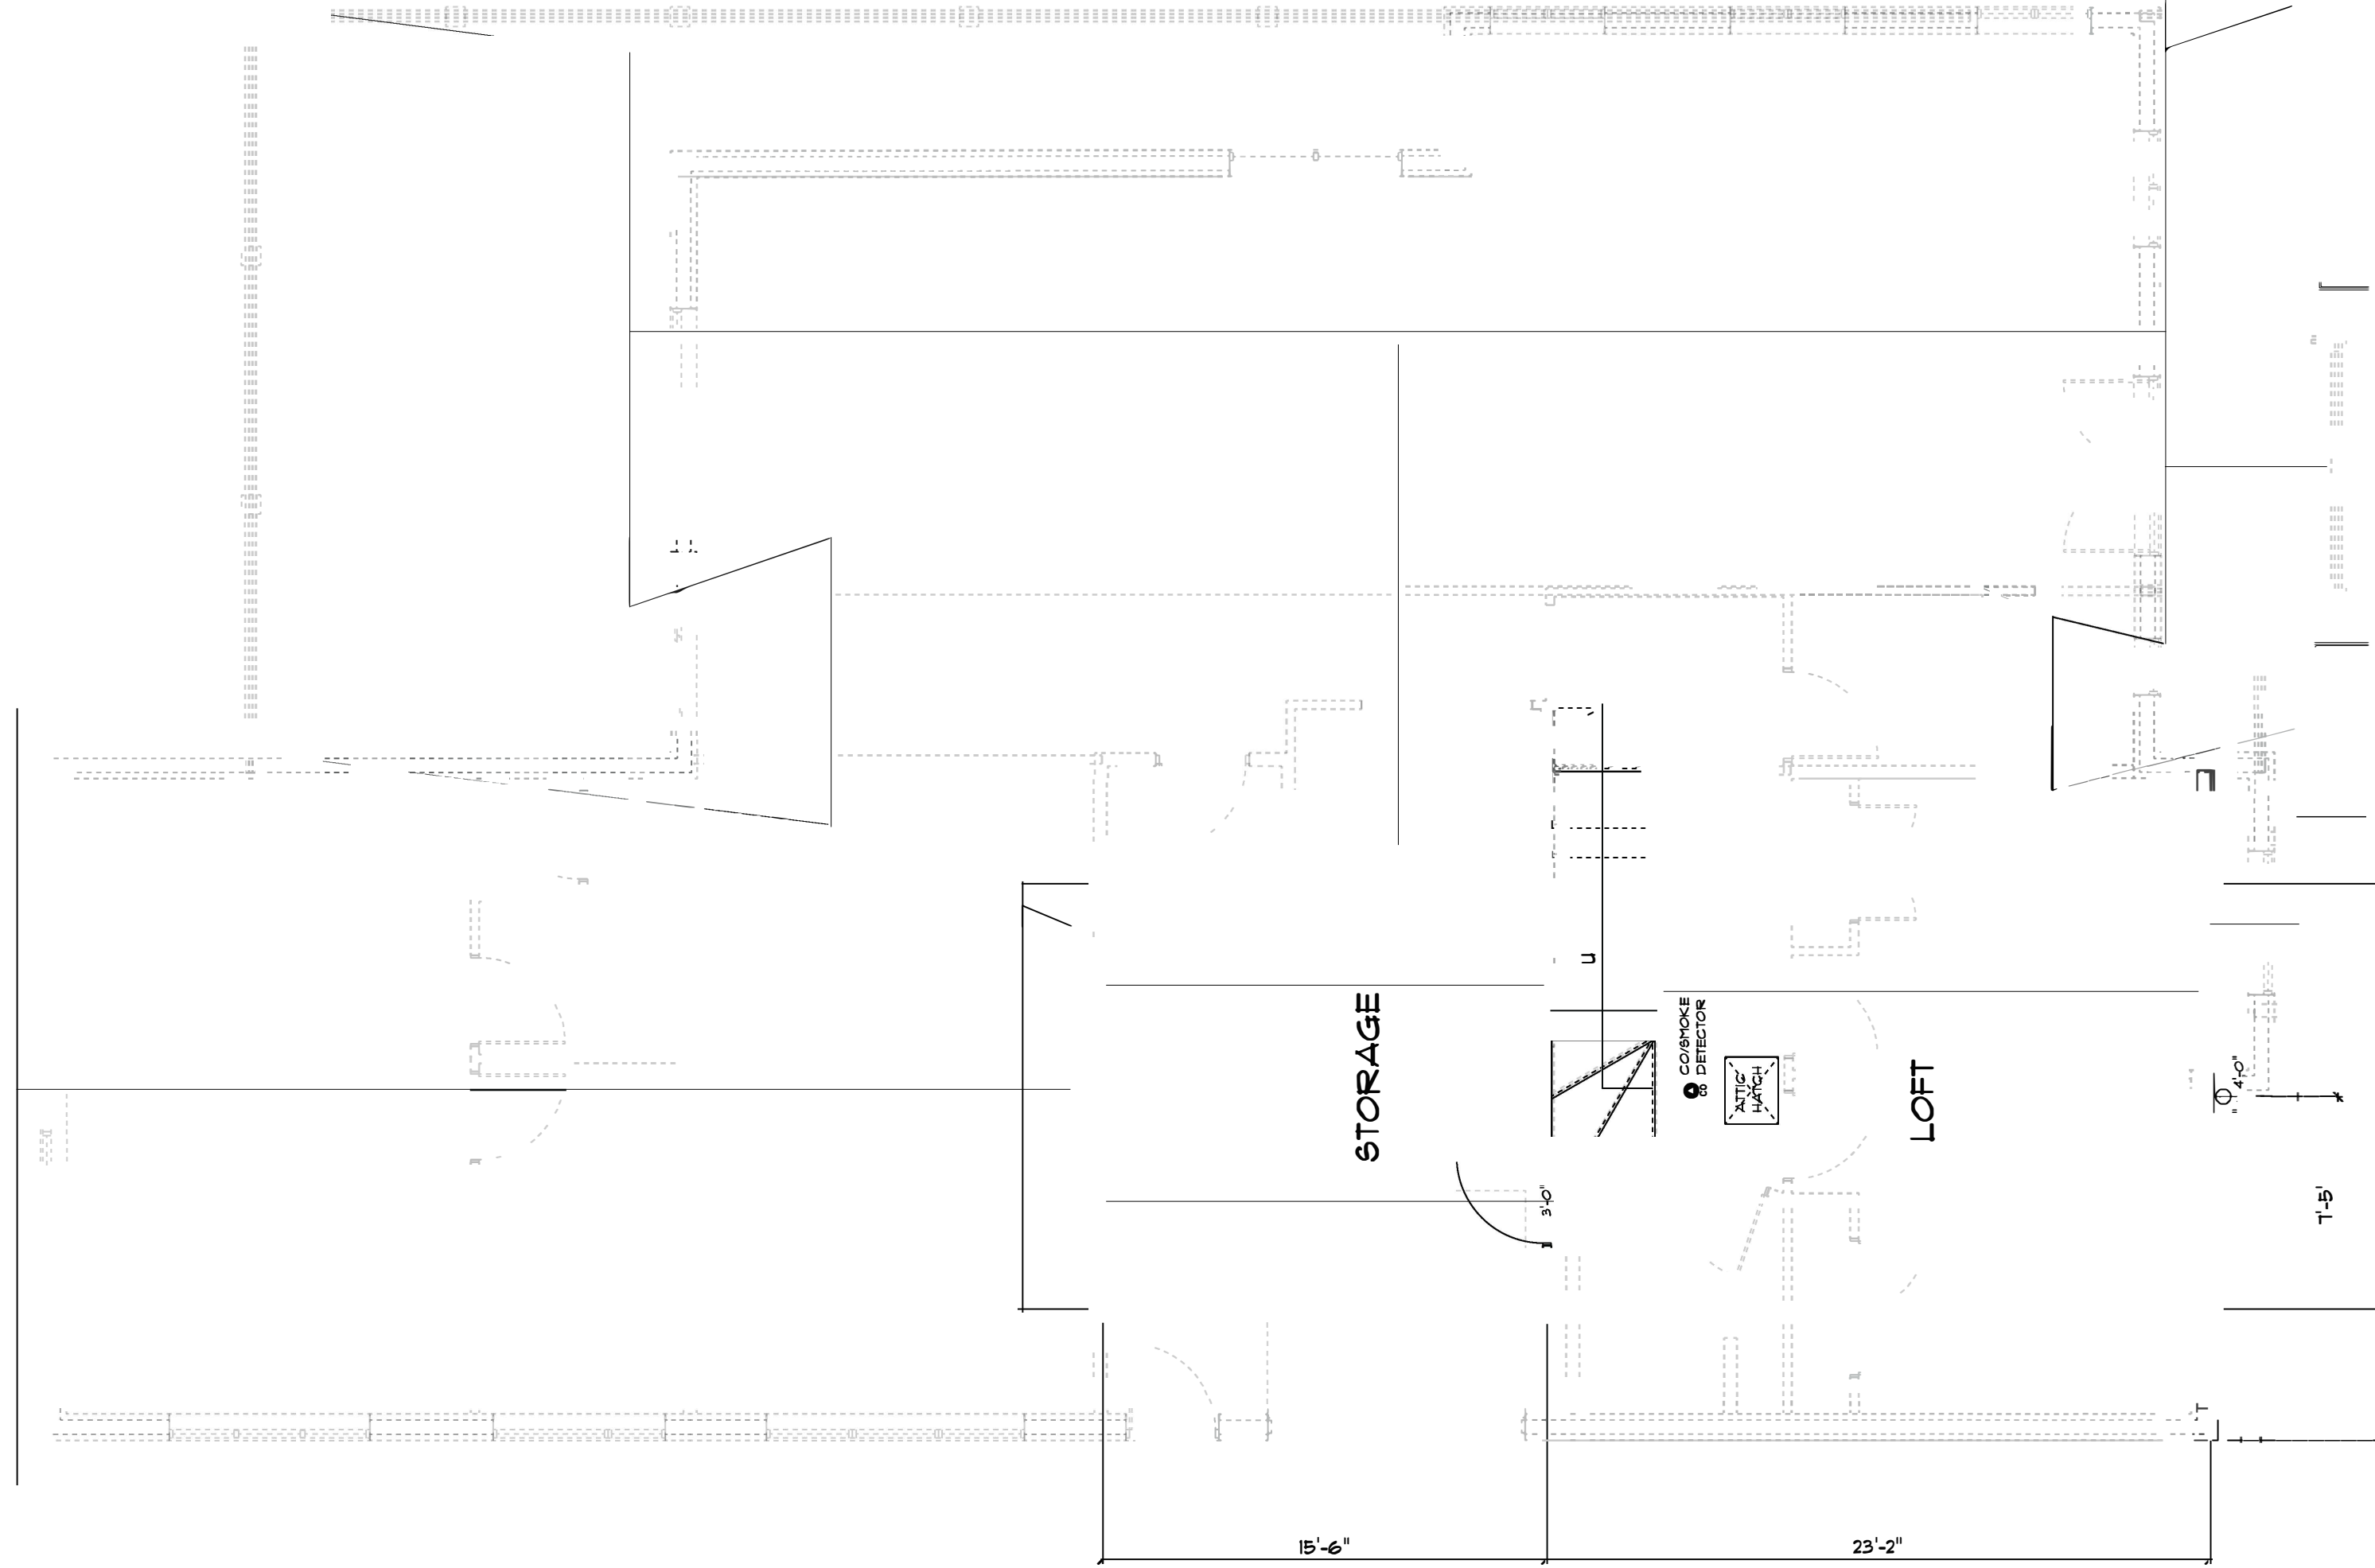

LOFT PLAN
 SCALE: 3/16" = 1'-0"

AREA SCHEDULE	
NAME	AREA
Gross Floor Area	587 sq. ft.

ELECTRICAL LAYO T
 SPEC. BY OWNER
HEATING SYSTEM
 SPEC. BY OWNER